

—

ARDREY KELL HIGH SCHOOL  
10220 ARDREY KELL ROAD  
CHARLOTTE, NC  
28277

PROJECT NAME:

DATE:

DRAWN BY:

BLOCK #:

AKHS


XX/XX/XXXX

NAME

PERIOD



REVISION DATES:

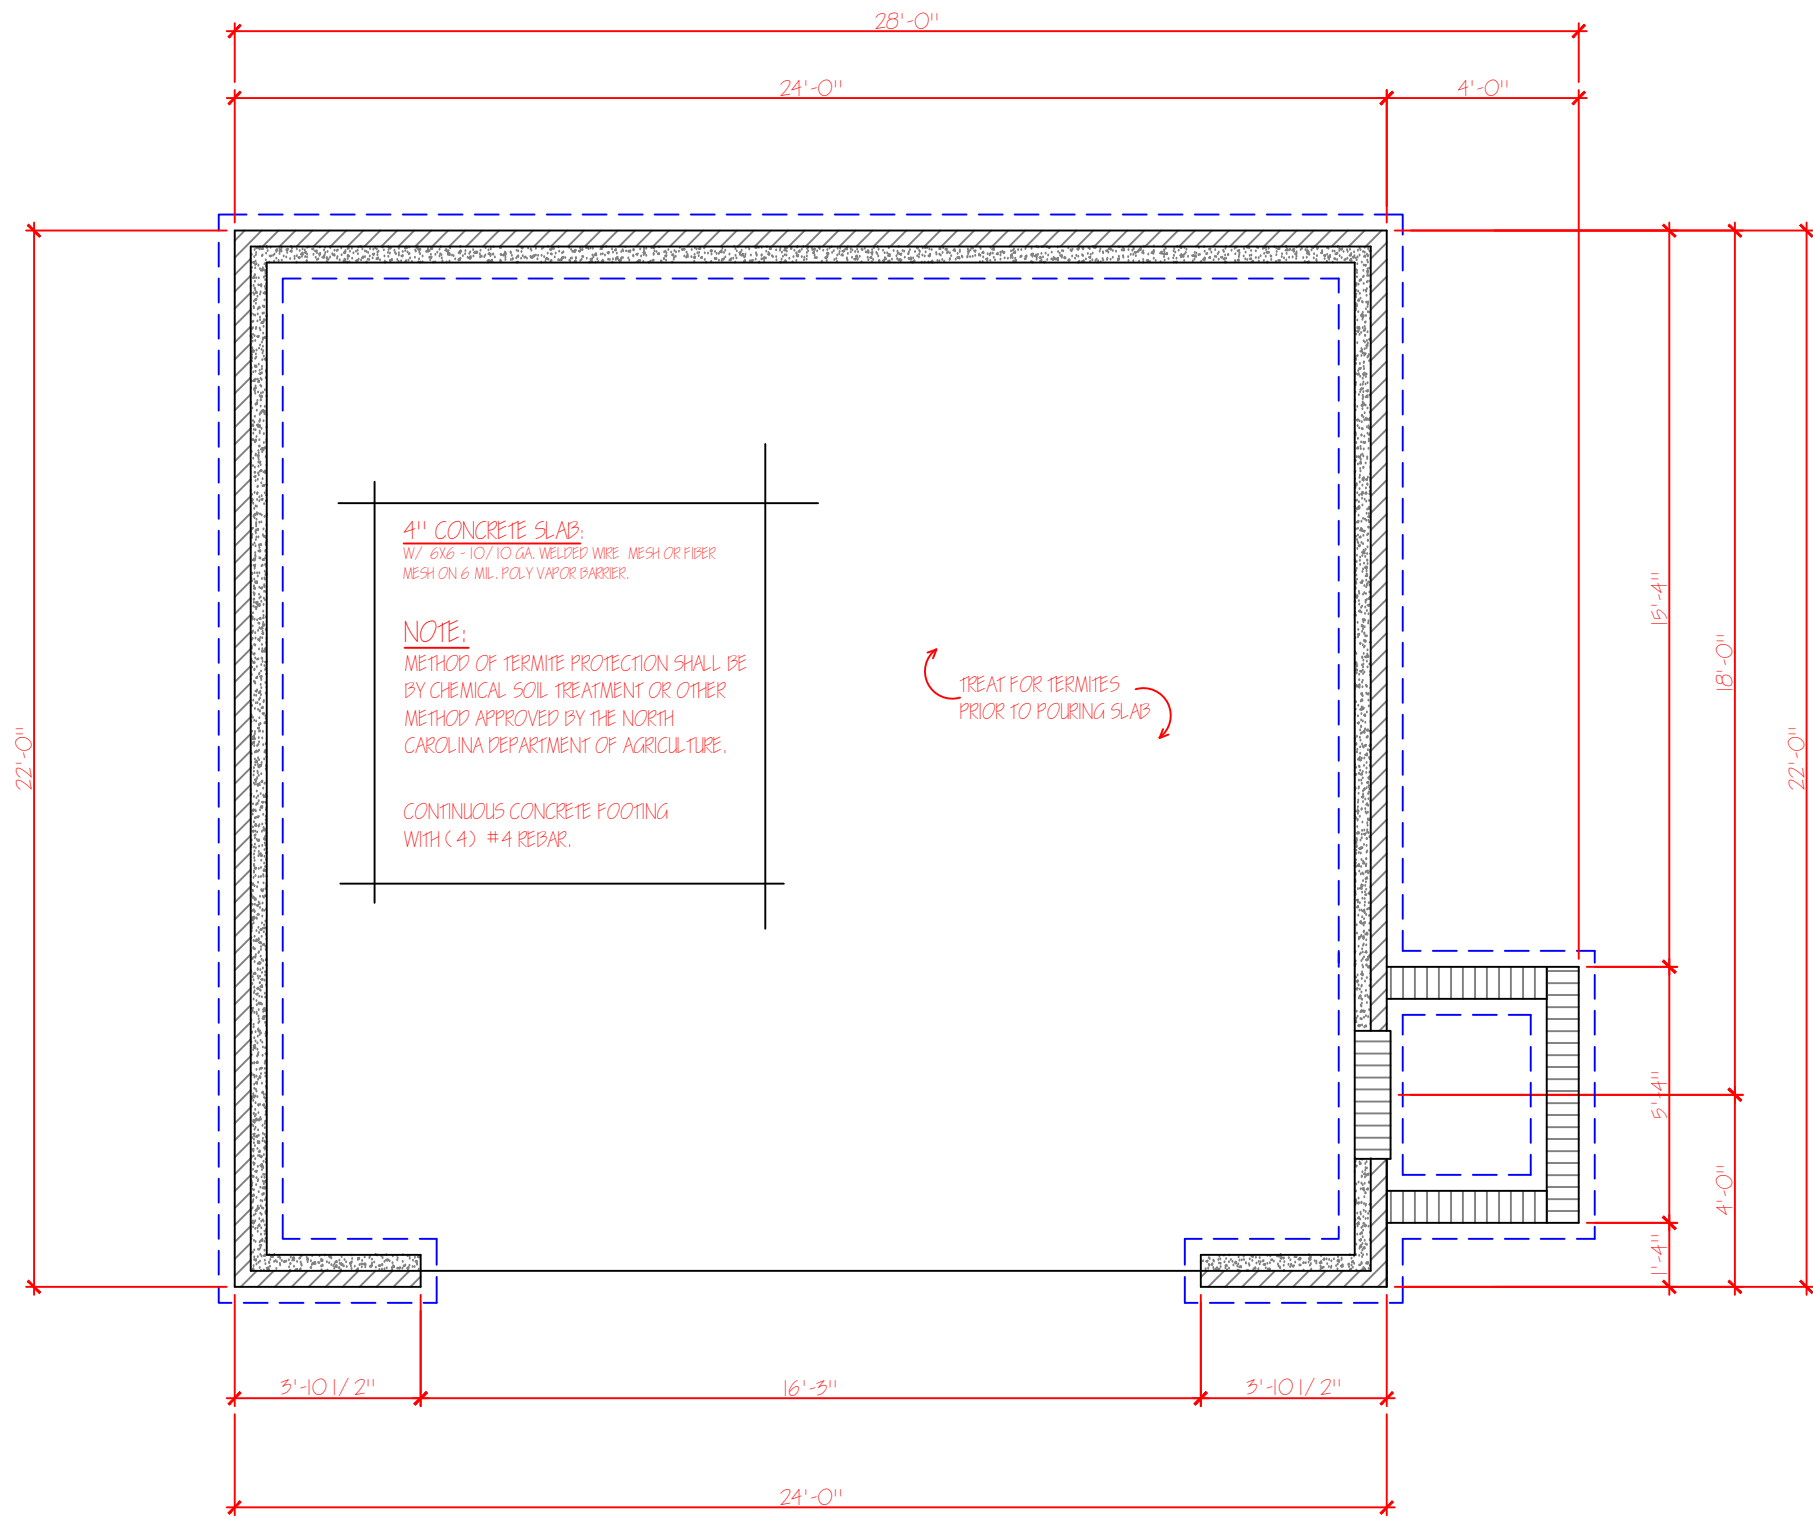4" CONCRETE SLAB;  
 W/ 6X6 - 10/10 GA. WELDED WIRE MESH OR FIBER  
 MESH ON 6 MIL. POLY VAPOR BARRIER.

NOTE:  
 METHOD OF TERMITE PROTECTION SHALL BE  
 BY CHEMICAL SOIL TREATMENT OR OTHER  
 METHOD APPROVED BY THE NORTH  
 CAROLINA DEPARTMENT OF AGRICULTURE.

CONTINUOUS CONCRETE FOOTING  
 WITH (4) #4 REBAR.

TREAT FOR TERMITES  
 PRIOR TO POURING SLAB


⊙ SLAB FOUNDATION

REVISION DATES:	



PROJECT NAME:	AKHS
DATE:	XX/XX/XXXX
DRAWN BY:	NAME
BLOCK #:	PERIOD

ARDREY KELL HIGH SCHOOL  
 10220 ARDREY KELL ROAD  
 CHARLOTTE, NC  
 28277

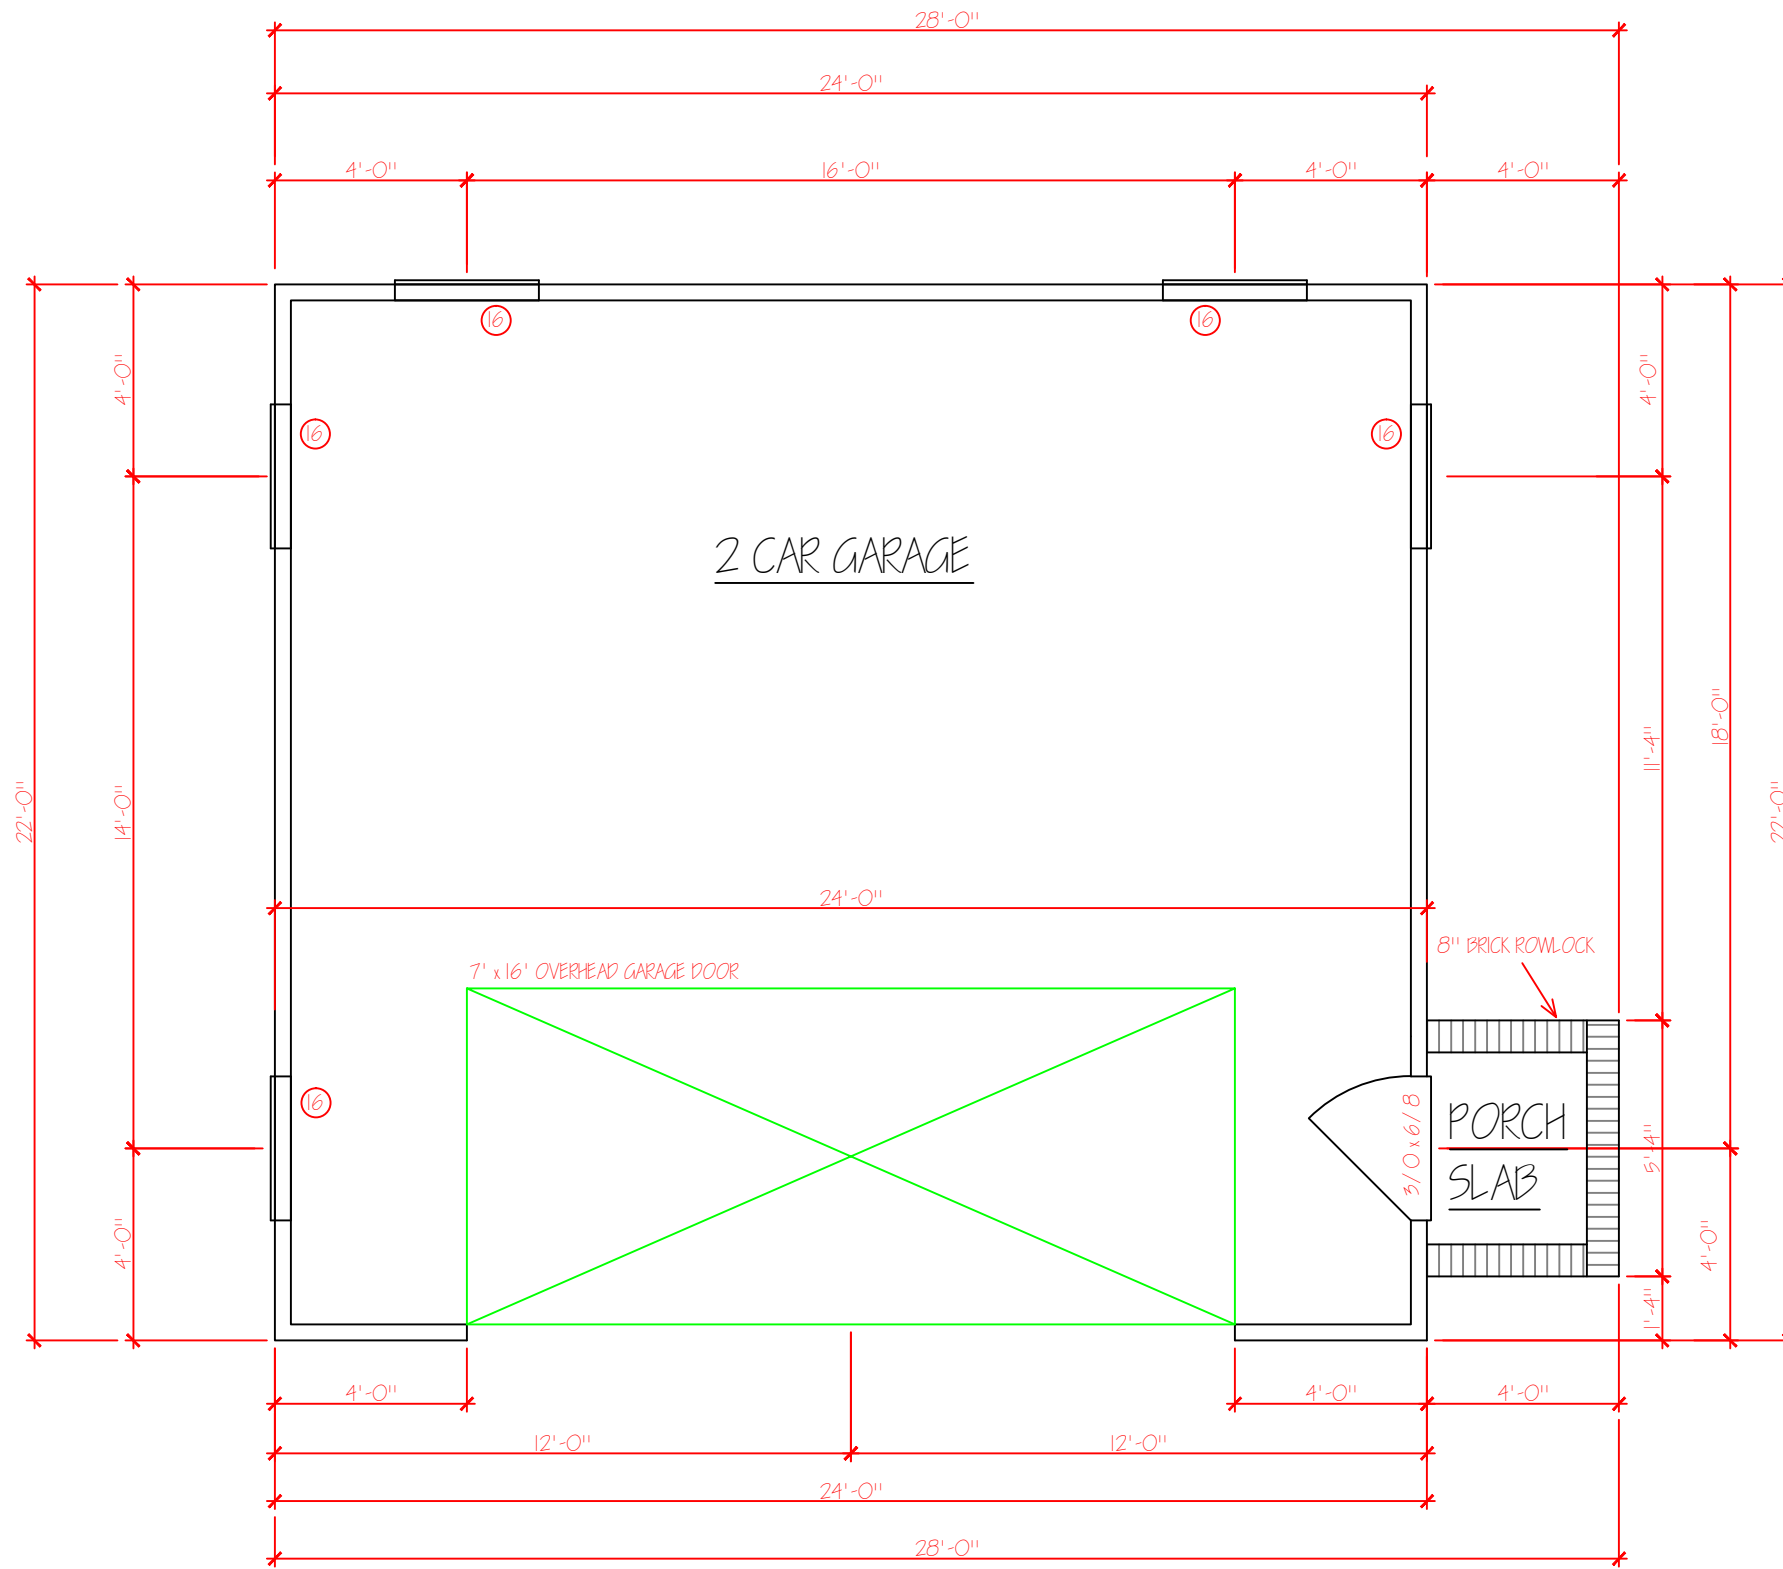

⊙ FLOOR PLAN


REVISION DATES:



PROJECT NAME:	AKHS
DATE:	XX/XX/XXXX
DRAWN BY:	NAME
BLOCK #:	PERIOD

PROJECT NAME:	AKHS
DATE:	XX/XX/XXXX
DRAWN BY:	NAME
BLOCK #:	PERIOD

ARDREY KELL HIGH SCHOOL  
 10220 ARDREY KELL ROAD  
 CHARLOTTE, NC  
 28277

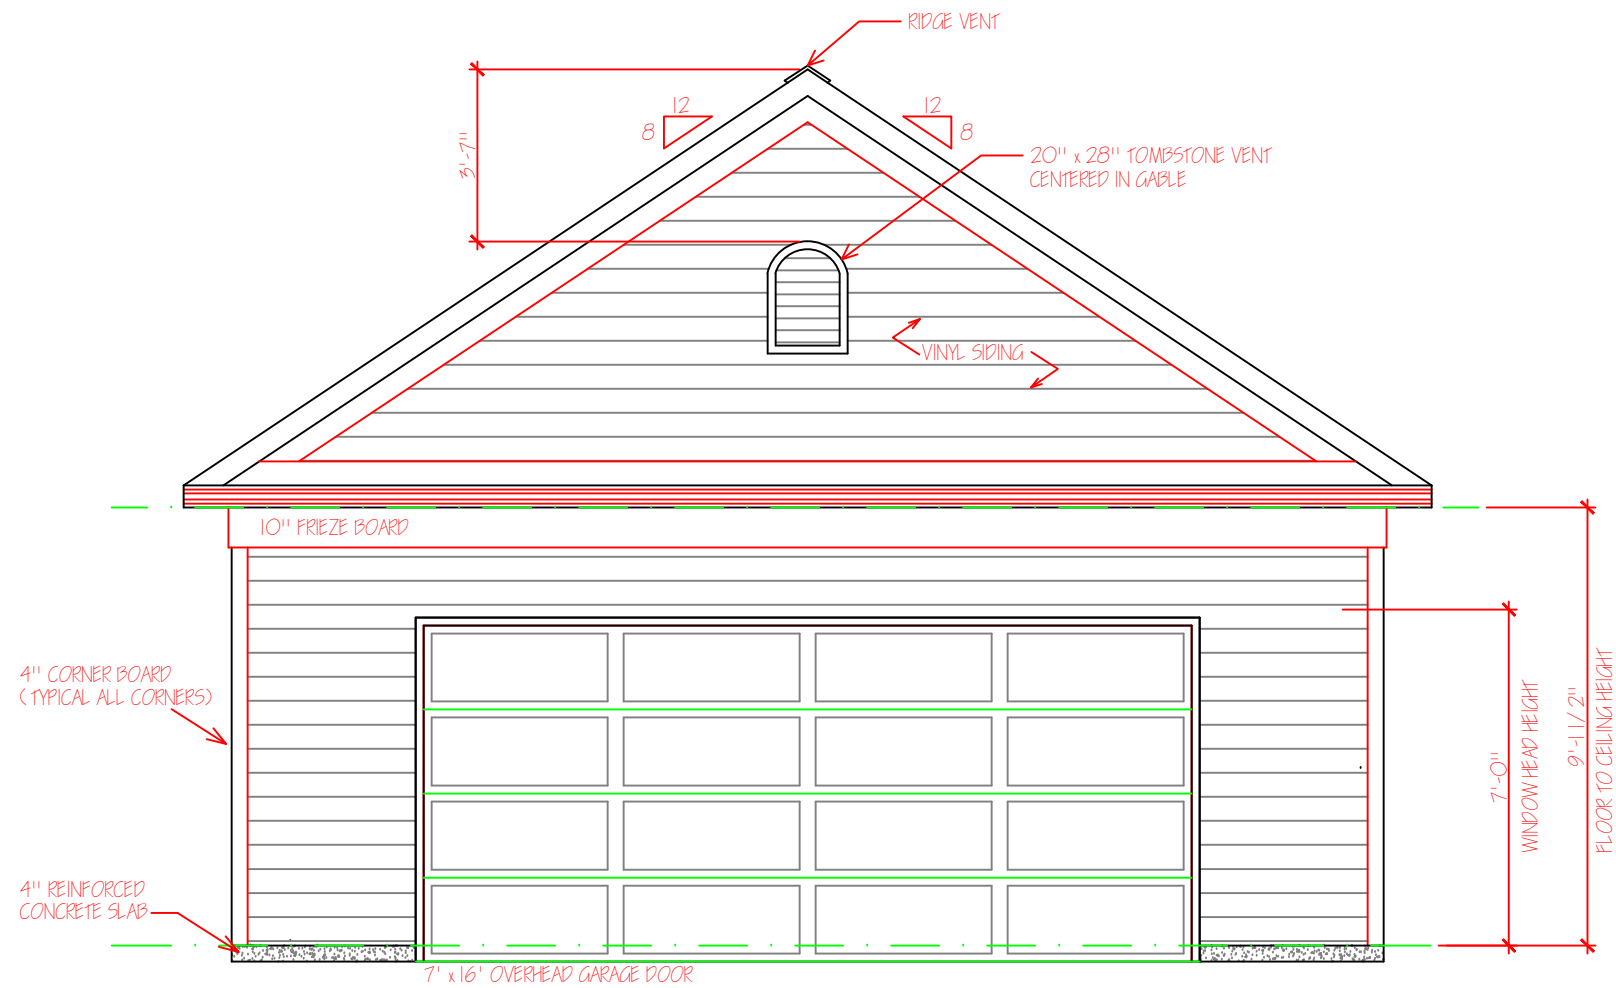

⊙ SOUTH ELEVATION


REVISION DATES:	



PROJECT NAME:	AKHS
DATE:	XX/XX/XXXX
DRAWN BY:	NAME
BLOCK #:	PERIOD

ARDREY KELL HIGH SCHOOL  
 10220 ARDREY KELL ROAD  
 CHARLOTTE, NC  
 28277

4

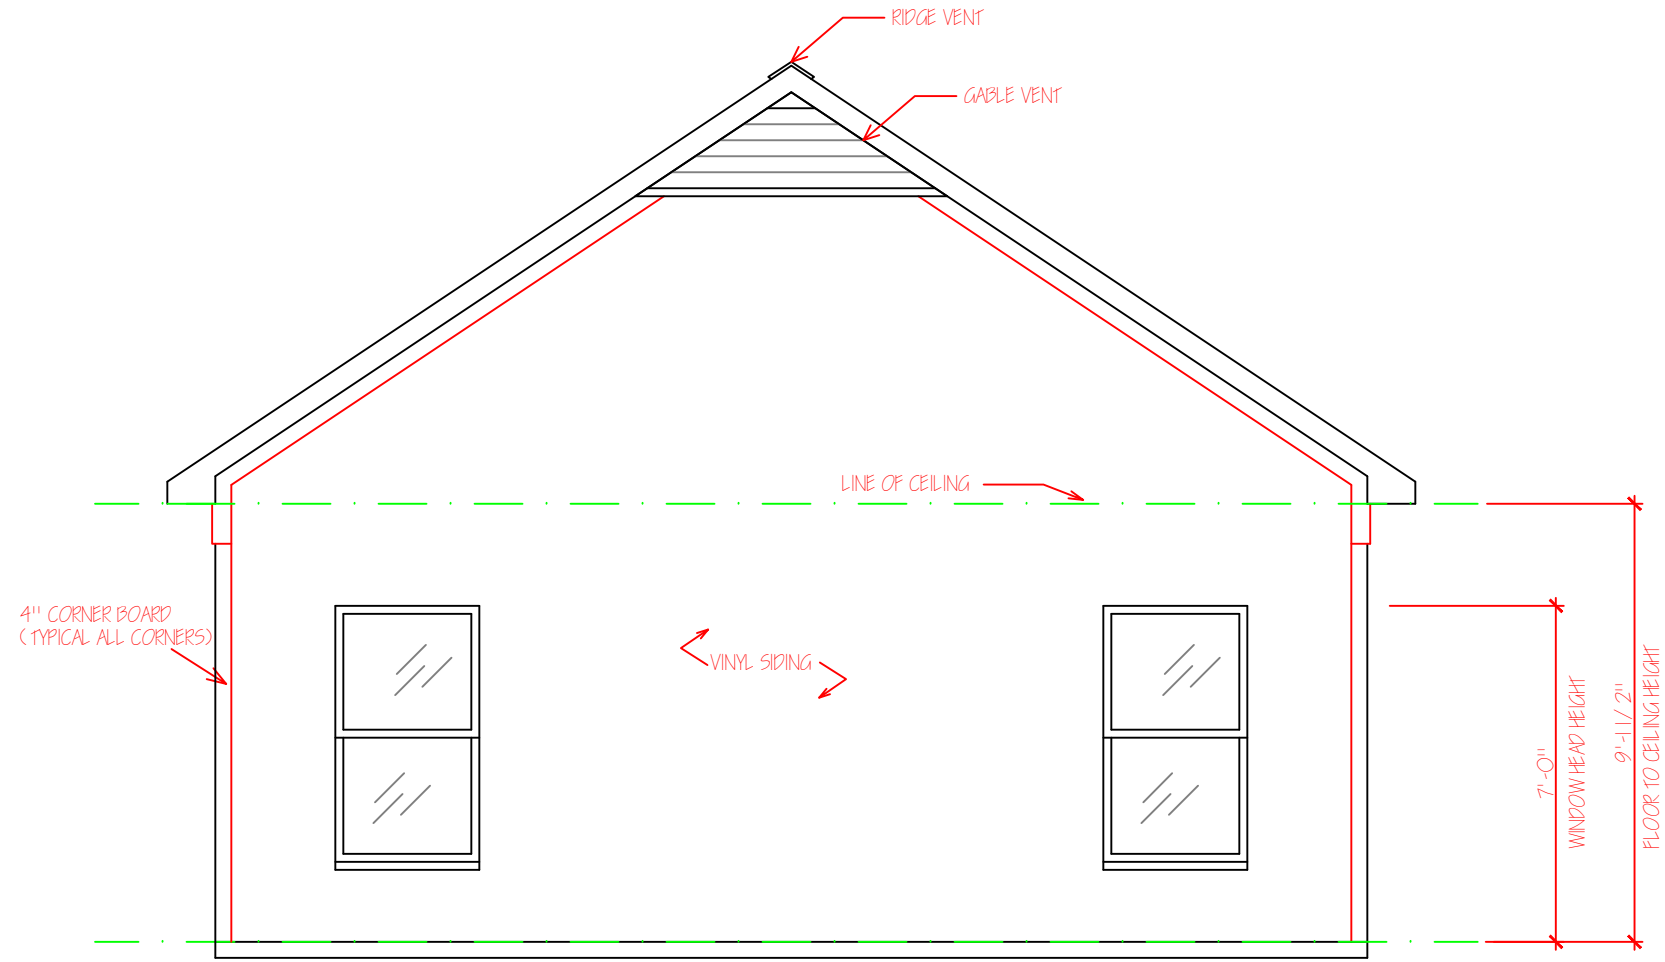

⊙ NORTH ELEVATION

REVISION DATES:




PROJECT NAME:	AKHS
DATE:	XX/XX/XXXX
DRAWN BY:	NAME
BLOCK #:	PERIOD

PROJECT NAME:	AKHS
DATE:	XX/XX/XXXX
DRAWN BY:	NAME
BLOCK #:	PERIOD

ARDREY KELL HIGH SCHOOL  
 10220 ARDREY KELL ROAD  
 CHARLOTTE, NC  
 28277

5

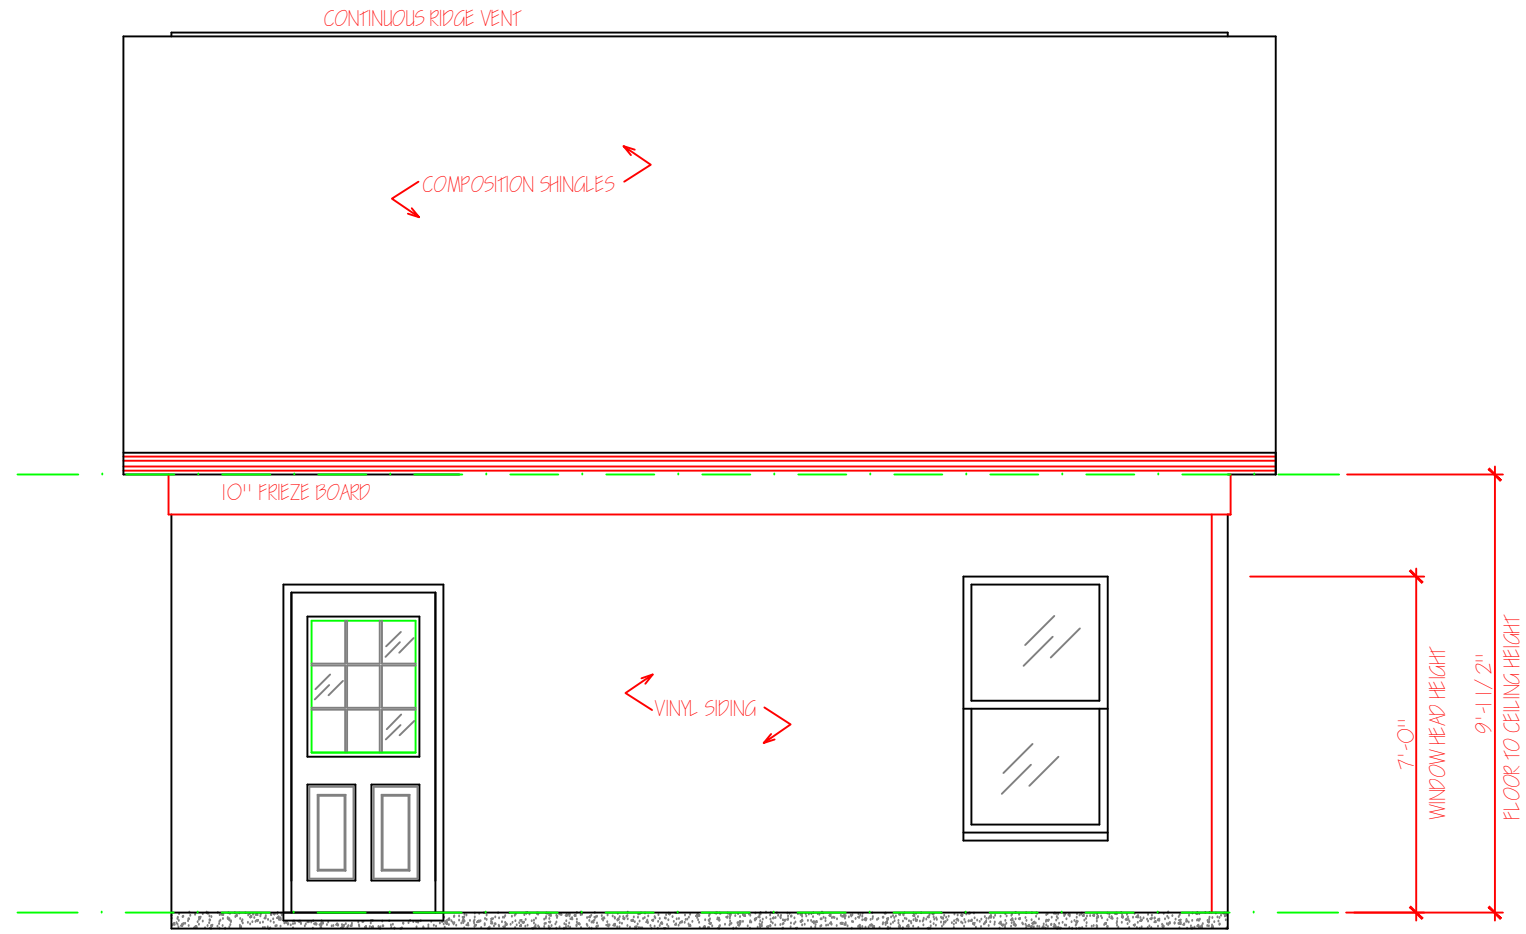

⊙ EAST ELEVATION


ARDREY KELL HIGH SCHOOL  
 10220 ARDREY KELL ROAD  
 CHARLOTTE, NC  
 28277

PROJECT NAME: AKHS  
 DATE: XX/XX/XXXX  
 DRAWN BY: NAME  
 BLOCK #: PERIOD



REVISION DATES:	

6

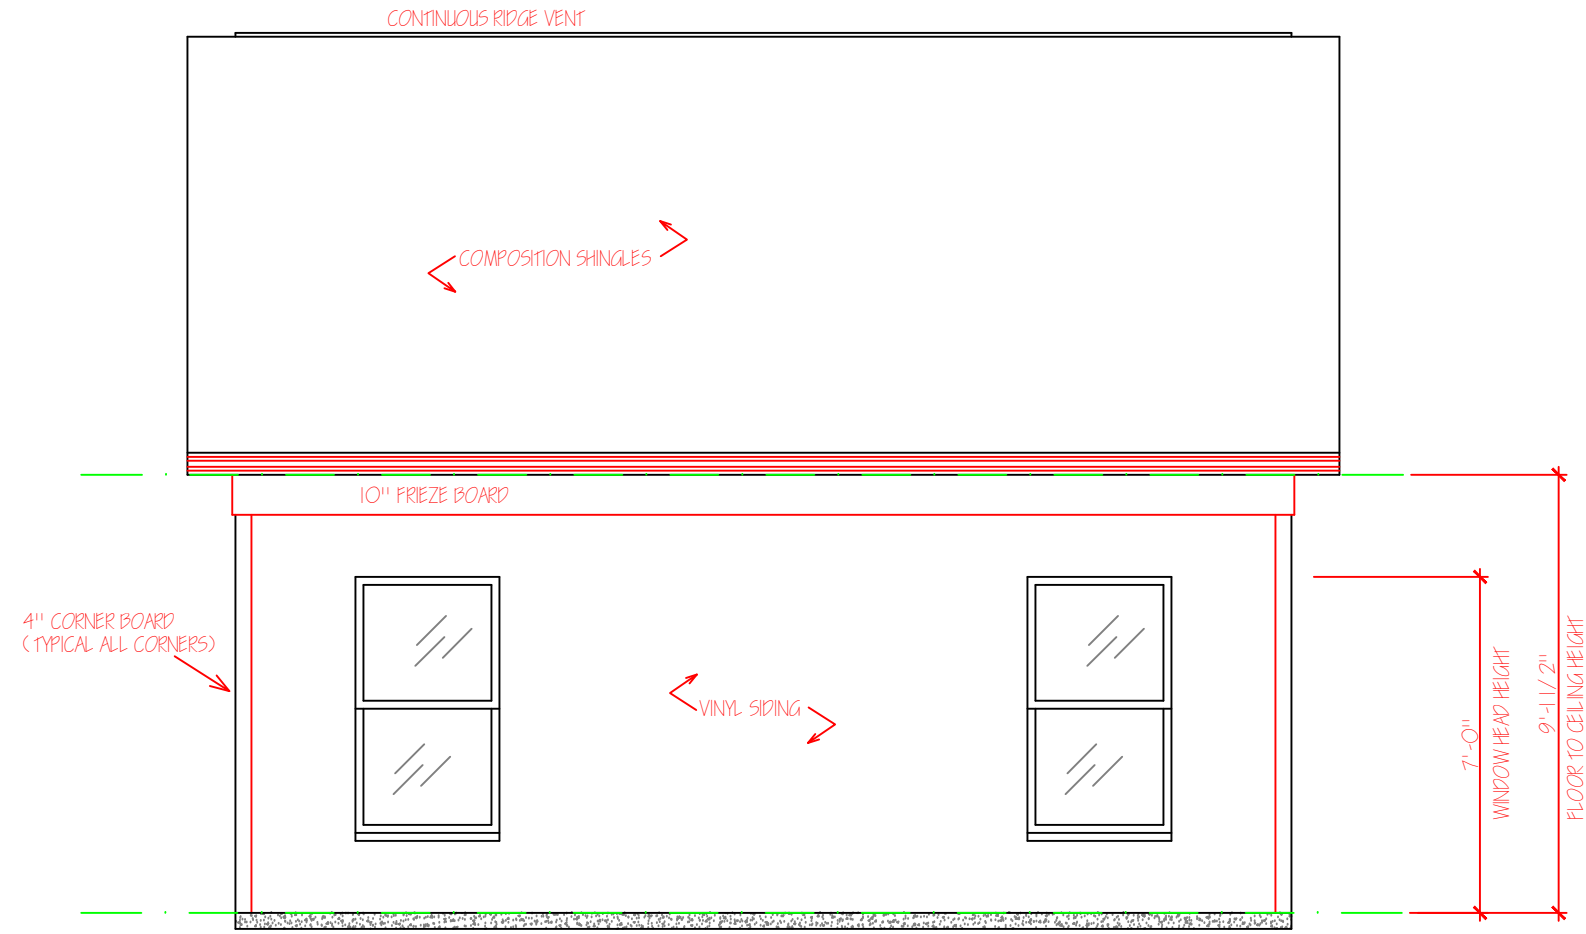

⊙ WEST ELEVATION


ARDREY KELL HIGH SCHOOL  
 10220 ARDREY KELL ROAD  
 CHARLOTTE, NC  
 28277

PROJECT NAME: AKHS  
 DATE: XX/XX/XXXX  
 DRAWN BY: NAME  
 BLOCK #: PERIOD



REVISION DATES:	

7

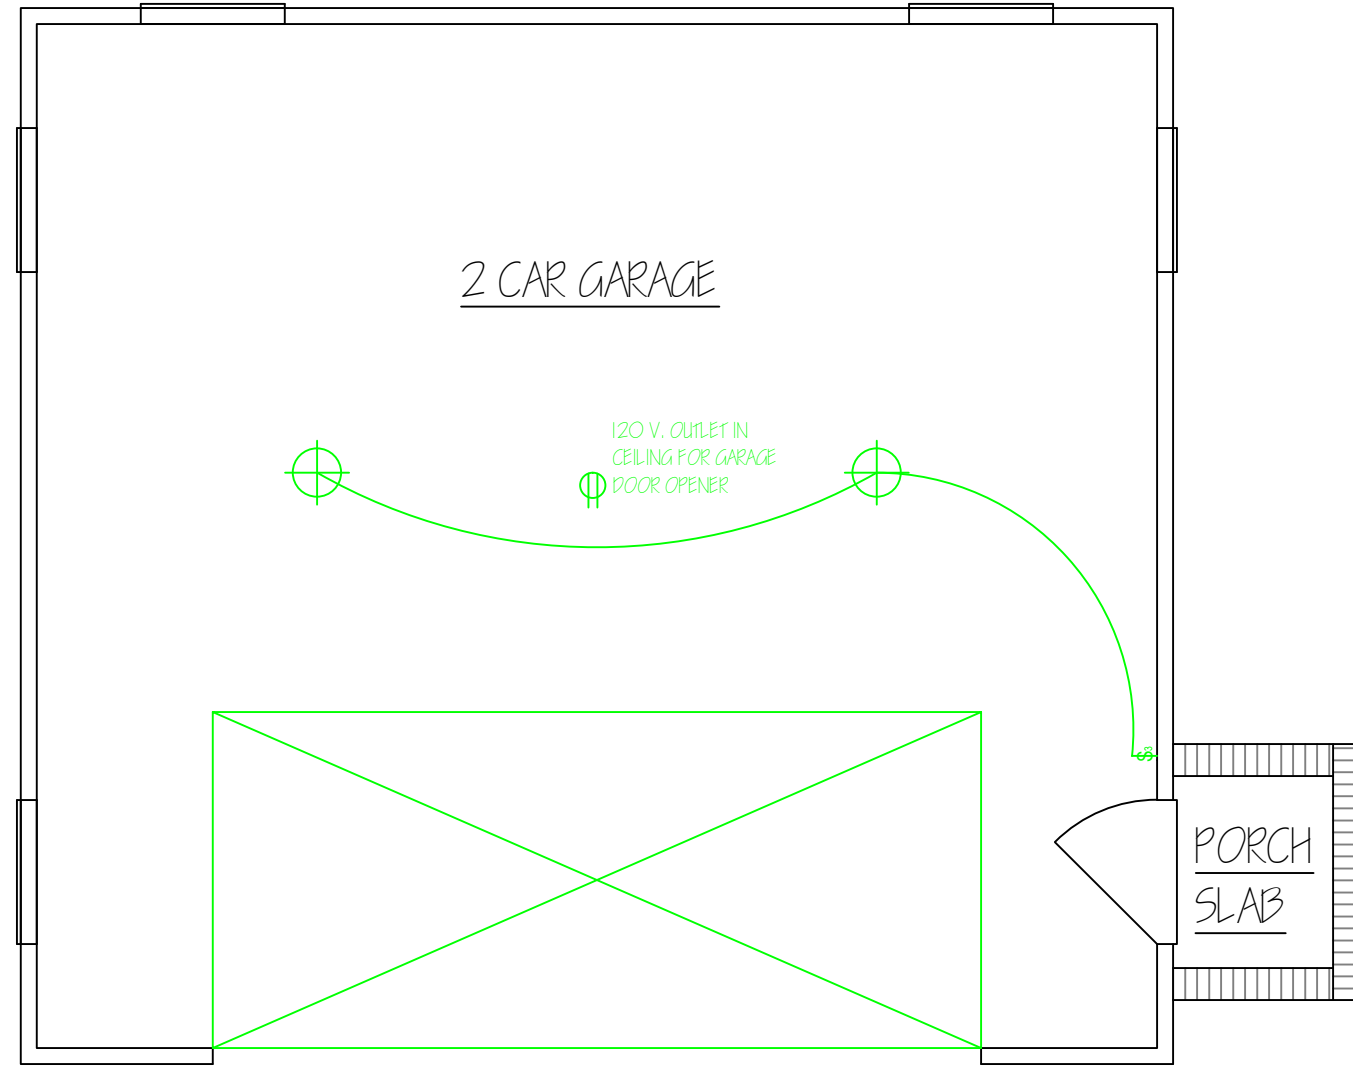

⊙ ELECTRICAL LAYOUT

ARDREY KELL HIGH SCHOOL  
 10220 ARDREY KELL ROAD  
 CHARLOTTE, NC  
 28277

PROJECT NAME: AKHS  
 DATE: XX/XX/XXXX  
 DRAWN BY: NAME  
 BLOCK #: PERIOD



REVISION DATES:	



WINDOW SCHEDULE							
SINGLE HUNG WINDOW SCHEDULE				DOUBLE HUNG WINDOW SCHEDULE			
TAG	SIZE & DESCRIPTION	TAG	SIZE & DESCRIPTION	TAG	SIZE & DESCRIPTION	TAG	SIZE & DESCRIPTION
1	2/0 x 2/0 SINGLE HUNG	18	(2) 2/0 x 2/0 SINGLE HUNG	55	2/0 x 2/0 DOUBLE HUNG	62	(2) 2/0 x 2/0 DOUBLE HUNG
2	2/0 x 3/0 SINGLE HUNG	19	(2) 2/0 x 3/0 SINGLE HUNG	56	2/0 x 3/0 DOUBLE HUNG	63	(2) 2/0 x 3/0 DOUBLE HUNG
3	2/0 x 4/0 SINGLE HUNG	20	(2) 2/0 x 4/0 SINGLE HUNG	57	2/0 x 4/0 DOUBLE HUNG	64	(2) 2/0 x 4/0 DOUBLE HUNG
4	2/0 x 5/0 SINGLE HUNG	21	(2) 2/0 x 5/0 SINGLE HUNG	58	2/0 x 5/0 DOUBLE HUNG	65	(2) 2/0 x 5/0 DOUBLE HUNG
5	2/0 x 6/0 SINGLE HUNG	22	(2) 2/0 x 6/0 SINGLE HUNG	59	2/0 x 6/0 DOUBLE HUNG	66	(2) 2/0 x 6/0 DOUBLE HUNG
6	2/4 x 3/0 SINGLE HUNG	23	(2) 2/4 x 3/0 SINGLE HUNG	40	2/4 x 3/0 DOUBLE HUNG	67	(2) 2/4 x 3/0 DOUBLE HUNG
7	2/4 x 4/0 SINGLE HUNG	24	(2) 2/4 x 4/0 SINGLE HUNG	41	2/4 x 4/0 DOUBLE HUNG	68	(2) 2/4 x 4/0 DOUBLE HUNG
8	2/4 x 5/0 SINGLE HUNG	25	(2) 2/4 x 5/0 SINGLE HUNG	42	2/4 x 5/0 DOUBLE HUNG	69	(2) 2/4 x 5/0 DOUBLE HUNG
9	2/4 x 6/0 SINGLE HUNG	26	(2) 2/4 x 6/0 SINGLE HUNG	43	2/4 x 6/0 DOUBLE HUNG	60	(2) 2/4 x 6/0 DOUBLE HUNG
10	2/8 x 3/0 SINGLE HUNG	27	(2) 2/8 x 3/0 SINGLE HUNG	44	2/8 x 3/0 DOUBLE HUNG	61	(2) 2/8 x 3/0 DOUBLE HUNG
11	2/8 x 4/0 SINGLE HUNG	28	(2) 2/8 x 4/0 SINGLE HUNG	45	2/8 x 4/0 DOUBLE HUNG	62	(2) 2/8 x 4/0 DOUBLE HUNG
12	2/8 x 5/0 SINGLE HUNG	29	(2) 2/8 x 5/0 SINGLE HUNG	46	2/8 x 5/0 DOUBLE HUNG	63	(2) 2/8 x 5/0 DOUBLE HUNG
13	2/8 x 6/0 SINGLE HUNG	30	(2) 2/8 x 6/0 SINGLE HUNG	47	2/8 x 6/0 DOUBLE HUNG	64	(2) 2/8 x 6/0 DOUBLE HUNG
14	3/0 x 3/0 SINGLE HUNG	31	(2) 3/0 x 3/0 SINGLE HUNG	48	3/0 x 3/0 DOUBLE HUNG	65	(2) 3/0 x 3/0 DOUBLE HUNG
15	3/0 x 4/0 SINGLE HUNG	32	(2) 3/0 x 4/0 SINGLE HUNG	49	3/0 x 4/0 DOUBLE HUNG	66	(2) 3/0 x 4/0 DOUBLE HUNG
16	3/0 x 5/0 SINGLE HUNG	33	(2) 3/0 x 5/0 SINGLE HUNG	50	3/0 x 5/0 DOUBLE HUNG	67	(2) 3/0 x 5/0 DOUBLE HUNG
17	3/0 x 6/0 SINGLE HUNG	34	(2) 3/0 x 6/0 SINGLE HUNG	51	3/0 x 6/0 DOUBLE HUNG	68	(2) 3/0 x 6/0 DOUBLE HUNG

⊙ SCHEDULE

REVISION DATES:





PROJECT NAME: AKHS  
DATE: XX/XX/XXXX  
DRAWN BY: NAME  
BLOCK #: PERIOD

ARDREY KELL HIGH SCHOOL  
10220 ARDREY KELL ROAD  
CHARLOTTE, NC  
28277

9